
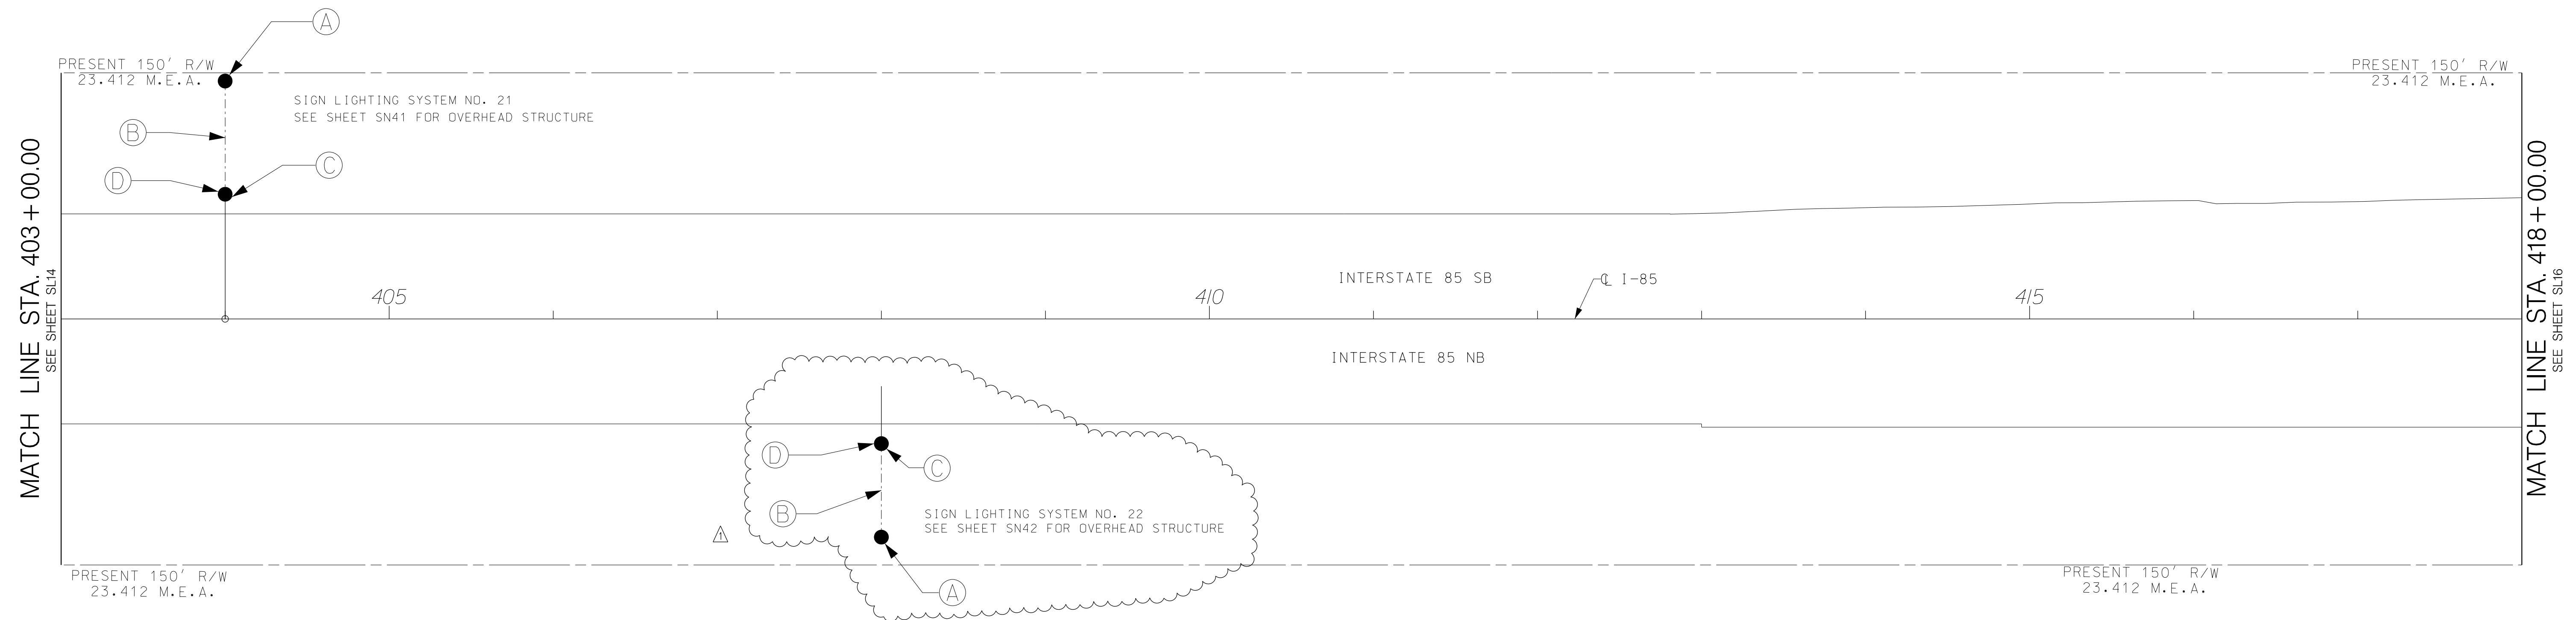




| FED. RD. DIV. NO. | STATE | COUNTY     | PROJECT ID  | ROUTE NO.    | SHEET NO. |
|-------------------|-------|------------|-------------|--------------|-----------|
| 3                 | S.C.  | GREENVILLE | 0038H - R02 | I-85 / I-385 | SL15      |

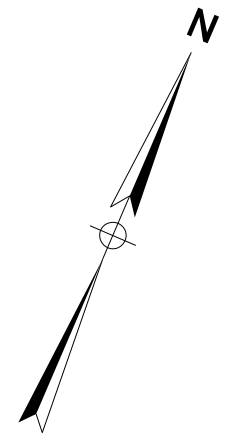

S:\Projects\2016\7171A\Design\Project - Pin Number\Tr-off\Signing\INTERCHANGE\SIGN LIGHTING SHEETS\SL05.dgn 7/26/2016


| REVISIONS |          | DESCRIPTION                                  | BY     | CHECKED | REVISIONS |      | DESCRIPTION | BY | CHECKED |
|-----------|----------|--|--------|---------|-----------|------|-------------|----|---------|
| NO.       | DATE     |  |        |         | NO.       | DATE |             |    |         |
| 1         | 04/07/16 | MOVED SIGN LIGHTING STRUCTURE TO STA. 408+00 | R.L.D. | B.G.N.  |           |      |             |    |         |
|           |          |  |        |         |           |      |             |    |         |
|           |          |  |        |         |           |      |             |    |         |

DRAWN BY : A.W.F.  
 DATE : 9/4/15  
 REVIEWED BY : D.R.R.  
 DATE : 9/4/15  
 APPROVED BY : B.G.N.  
 DATE : 9/4/15

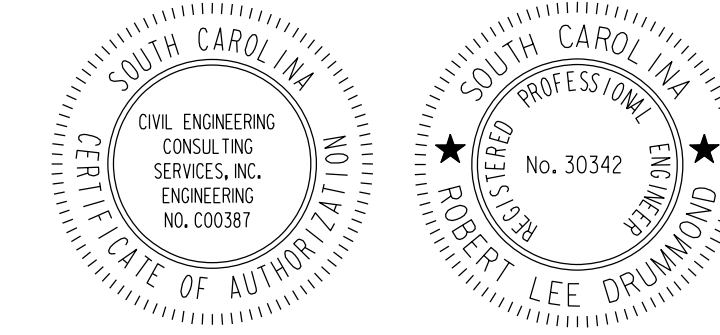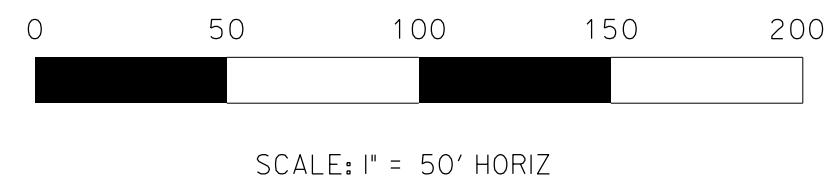

SOUTH CAROLINA DEPARTMENT OF TRANSPORTATION  
**SCDOT**  
 I-85 / I-385 INTERCHANGE  
 SIGN LIGHTING PLAN SHEET  
 STA. 403+00.00 TO STA. 418+00.00


| FED. RD. DIV. NO. | STATE | COUNTY     | PROJECT ID  | ROUTE NO.    | SHEET NO. |
|-------------------|-------|------------|-------------|--------------|-----------|
| 3                 | S.C.  | GREENVILLE | 0038H - R02 | I-85 / I-385 | SL16      |

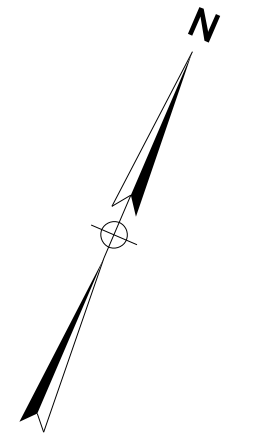

MATCH LINE STA. 418+00.00  
SEE SHEET SL15

MATCH LINE STA. 433+00.00  
SEE SHEET SL17

MATCH LINE STA. 55+00.00  
SEE SHEET SL17

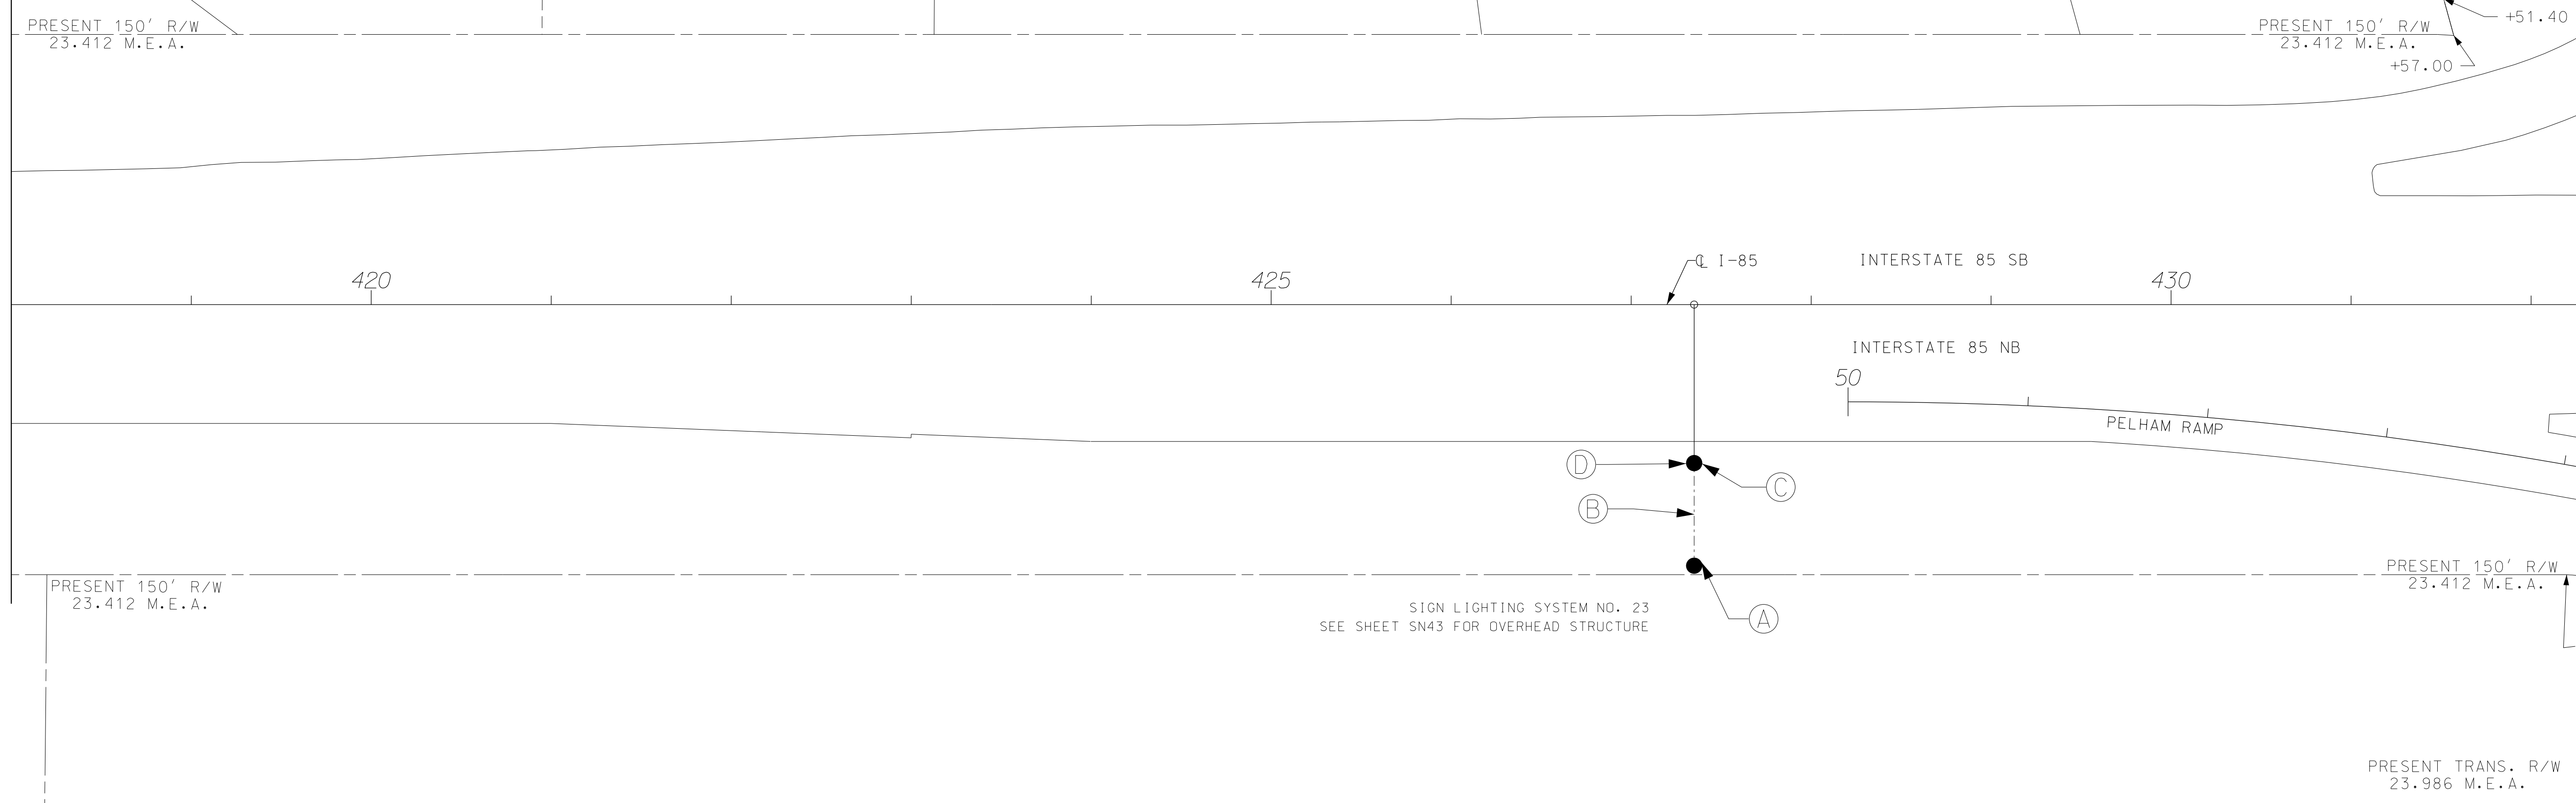

S:\Projects\2014\717A\Design\Project - Pin Number\Tr-of-fic\Signing\INTERCHANGE\SIGN LIGHTING SHEETS\SL016.dgn 7/26/2016

| REVISIONS |          | DESCRIPTION                    | BY     | CHECKED | REVISIONS |      | DESCRIPTION | BY | CHECKED |
|-----------|----------|--------------------------------|--------|---------|-----------|------|-------------|----|---------|
| NO.       | DATE     |                                |        |         | NO.       | DATE |             |    |         |
| 1         | 05/16/16 | RELOCATED OH-23 TO STA. 427+35 | R.L.D. | B.G.N.  |           |      |             |    |         |
|           |          |                                |        |         |           |      |             |    |         |
|           |          |                                |        |         |           |      |             |    |         |

DRAWN BY : A.W.F.  
DATE : 9/4/15


REVIEWED BY : D.R.R.  
DATE : 9/4/15

APPROVED BY : B.G.N.  
DATE : 9/4/15

**FLATIRON** **ZACHRY**  
a joint venture

**C E**  
**C S**

CIVIL ENGINEERING  
CONSULTING SERVICES, INC.

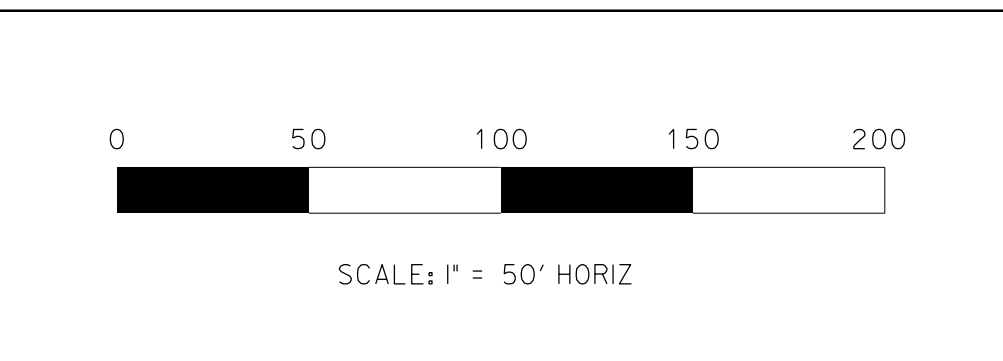

SOUTH CAROLINA  
REGISTERED PROFESSIONAL ENGINEER  
No. 30342  
ROBERT LEE DRUMMOND

SOUTH CAROLINA DEPARTMENT OF TRANSPORTATION

**SCDOT**  
South Carolina Department of Transportation

I-85 / I-385 INTERCHANGE

SIGN LIGHTING PLAN SHEET  
STA. 418+00.00 TO STA. 433+00.00